



Schenectady County  
Purchasing Department  
**ADDENDUM**

620 State St.-2nd Floor  
Schenectady, NY 12305  
[Purchasing@schenectadycounty.com](mailto:Purchasing@schenectadycounty.com)  
518.388.4240

---

**RFB-2022-55**

**ADDENDUM #1**

**SCHENECTADY COUNTY MAIN LIBRARY AHU REPLACEMENT**

9/27/2022

The purpose of this addendum is to provide detailed information to all Bidders. This addendum is hereby included in and made part of the Contract Documents, whether or not attached thereto. Receipt of this Addendum must be acknowledged on the bid form.

The following documents is hereby included in the documents posted on Bidnet and provided to plan holders:

**Please acknowledge this addendum on your bid form.**

**END OF ADDENDUM #1**




ME ENGINEERING  
Mechanical/Electrical Engineering Consultants

Capital District | Rochester | Syracuse | Buffalo  
413 STATE STREET, SUITE 410      518.533.2171  
SCHENECTADY, NY 12305      www.meengineering.com

**DRAWING NOTES**

1. AT COMPLETION OF INSTALL, REINSTALL ALL ITEMS TEMPORARILY REMOVED IN THE DEMOLITION PHASE AND INSULATE SHEET METAL SAFING WITH 3" RIGID INSULATION.
2. RE-INSTALL TEMPORARILY REMOVED DUCTWORK DUCTWORK AND REINSULATE AT COMPLETION OF WORK.
3. PROVIDE NEW PAD FULL SIZE OF UNIT AT GRADE LEVEL.
4. EXTEND (E)PAD TO FULL SIZE OF UNIT
5. COORDINATE COIL PULL SO COIL CAN BE PULLED IN AREA SHOWN.
6. EXISTING 40x40 ACCESS DOOR TO CRAWL SPACE.
7. SAFE OFF ENLARGED OPENING WITH 20 GAUGE SHEET METAL AND ANGLE IRON. SEAL OPENING ALL THE WAY AROUND.

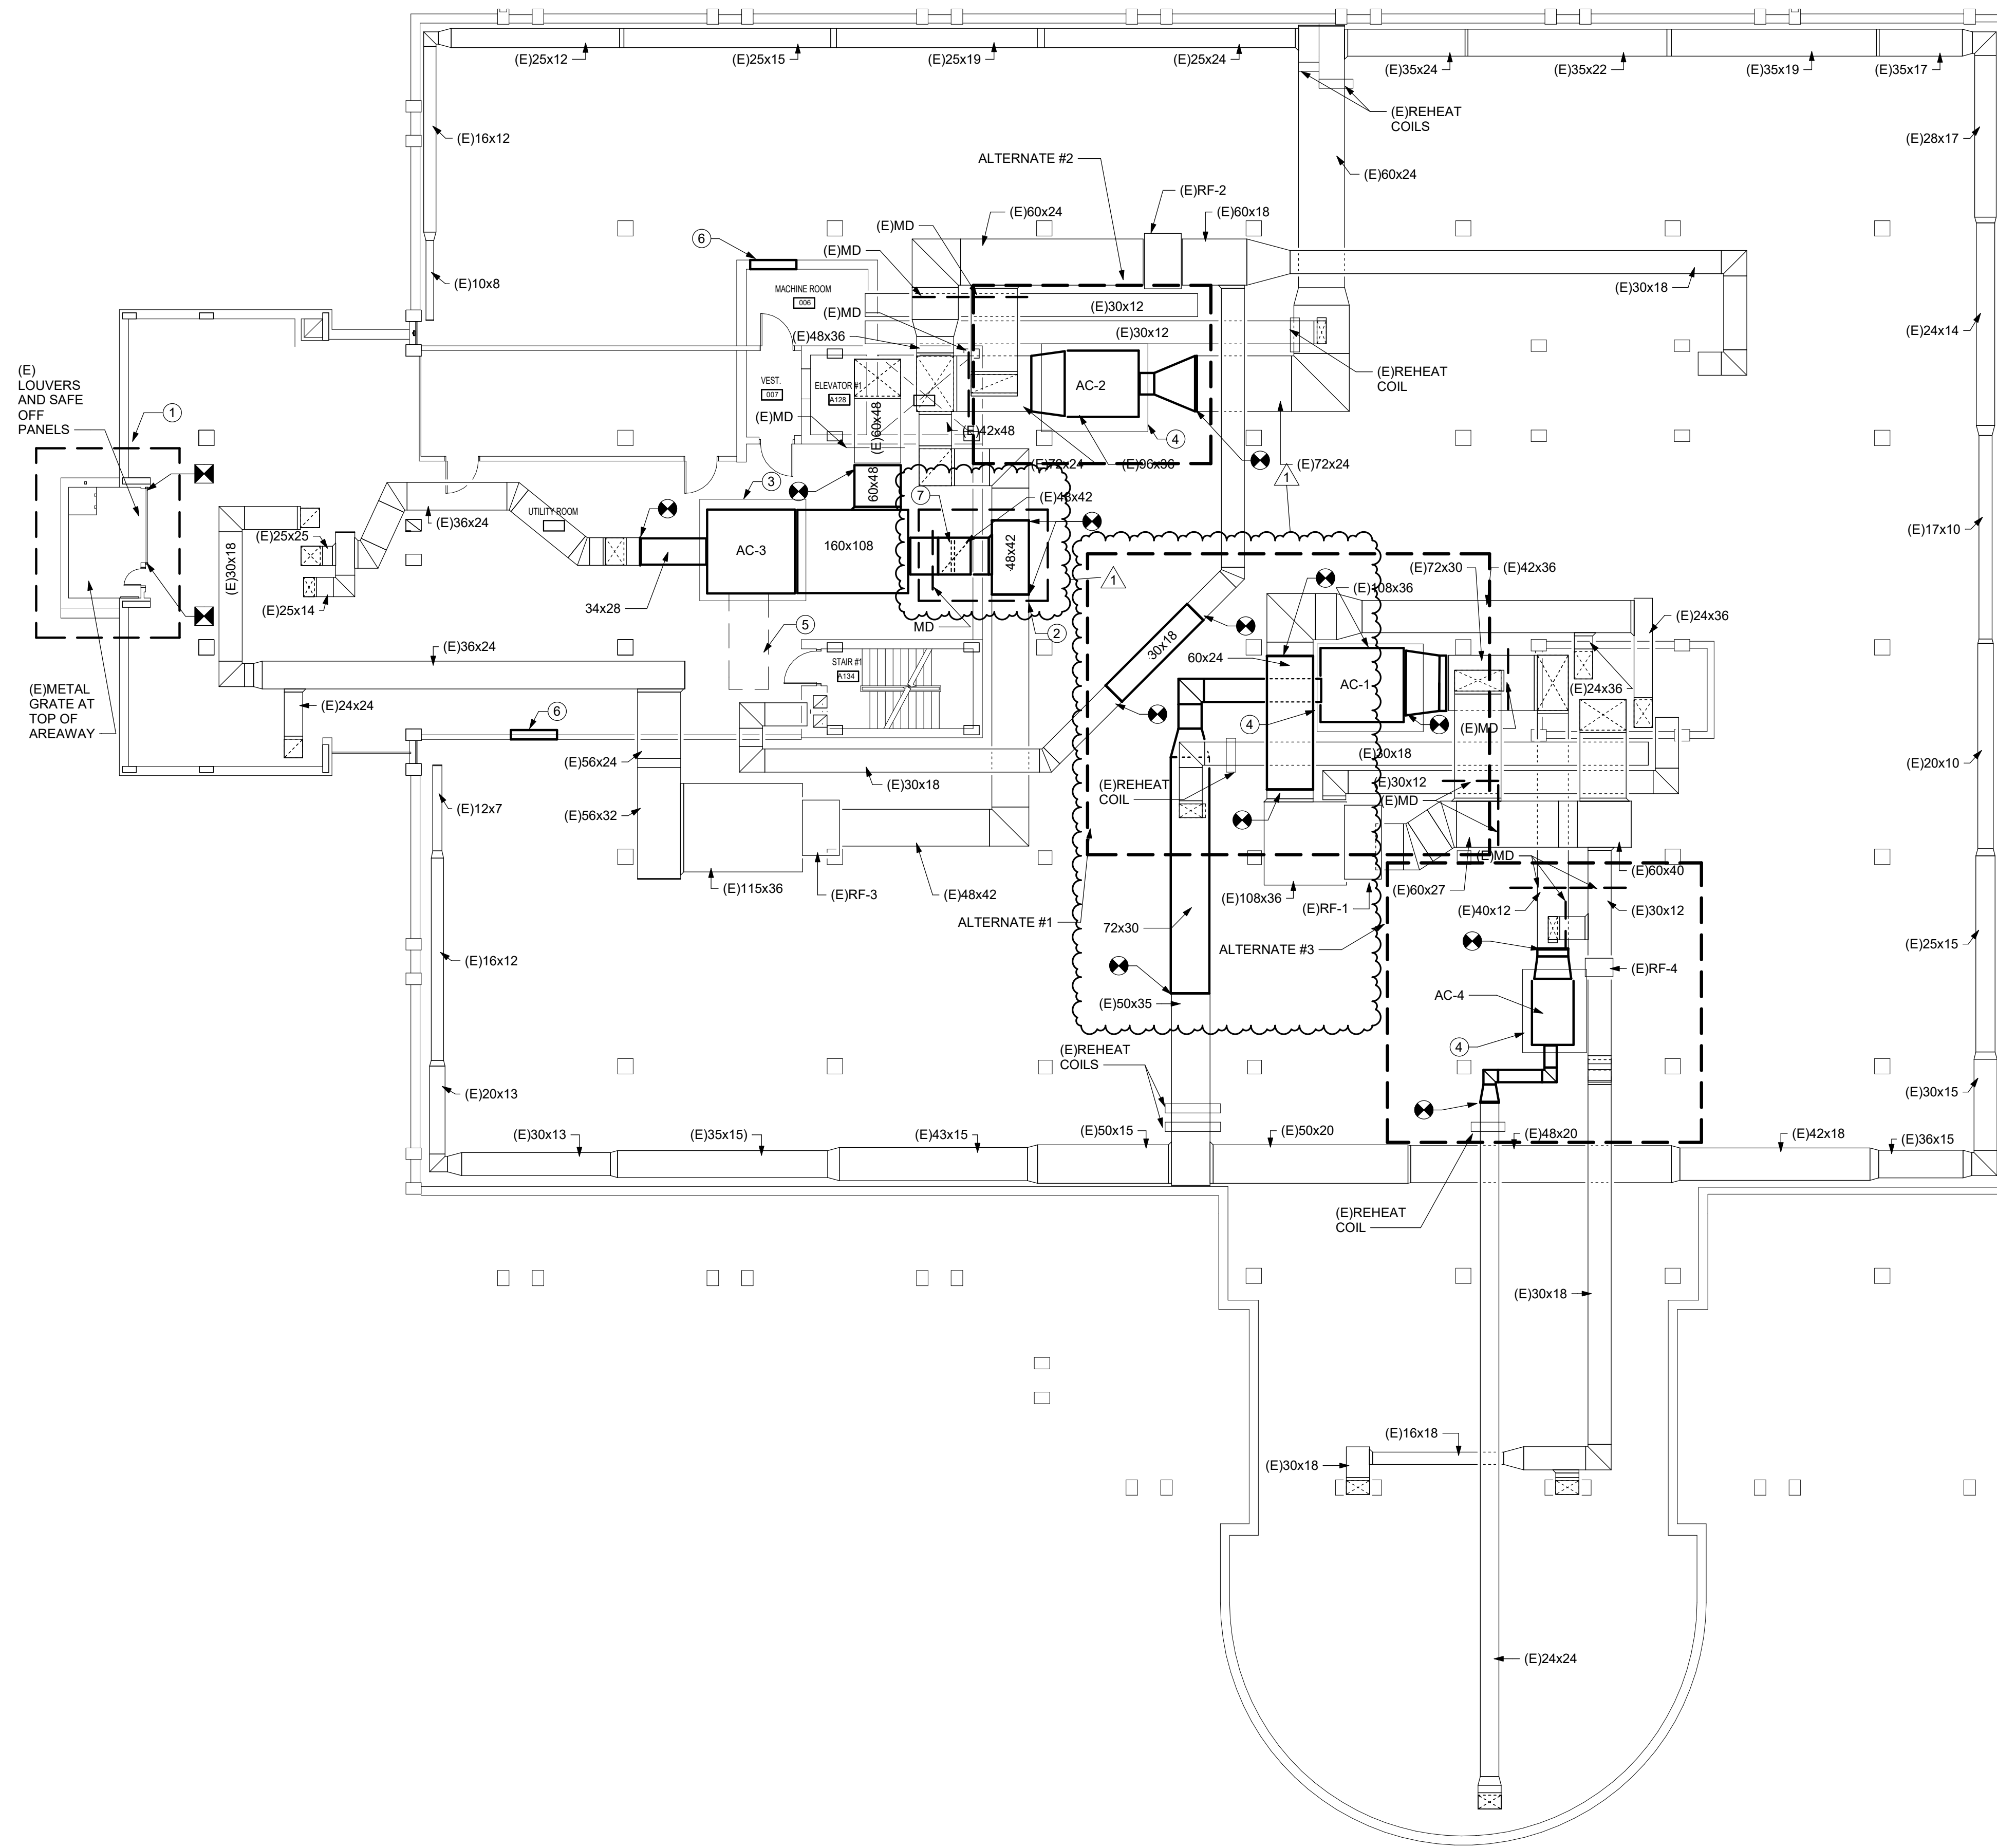

1 Basement Plan - New Ductwork  
3/32" = 1'-0"

SCHENECTADY COUNTY LIBRARY AHU  
REPLACEMENT RFB-2022-55  
99 CLINTON STREET  
SCHENECTADY, NY 12305



THESE DOCUMENTS AND ALL THE IDEAS, ARRANGEMENTS, DESIGNS AND PLANS INDICATED THEREON OR REPRESENTED THEREBY ARE OWNED BY AND REMAIN THE PROPERTY OF ME ENGINEERING AND NO PART THEREOF SHALL BE UTILIZED BY ANY PERSON, FIRM OR CORPORATION FOR ANY PURPOSE WHATSOEVER EXCEPT WITH THE SPECIFIC WRITTEN PERMISSION OF ME ENGINEERING, P.C.  
2021 © ME ENGINEERING, P.C.

No.	Date	By	Description
1	09/27/22	ME	ADDENDUM #1

DRAWING TITLE  
**BASEMENT  
DUCTWORK PLAN**

DRAWING NO.	Drawn By: CDM
<b>M100</b>	Checked By: MEK
	Project Mgr: BAB
	Project No: 213212


ISSUE DATE **09/02/2022**  
Project Status



**ENGINEERING**  
Mechanical/Electrical Engineering Consultants

Capital District | Rochester | Syracuse | Buffalo  
433 STATE STREET, SUITE 410  
SCHENECTADY, NY 12305 518.533.2171  
www.meeengineering.com

**SCHENECTADY COUNTY LIBRARY AHU  
REPLACEMENT RFB-2022-55  
99 CLINTON STREET  
SCHENECTADY, NY 12305**

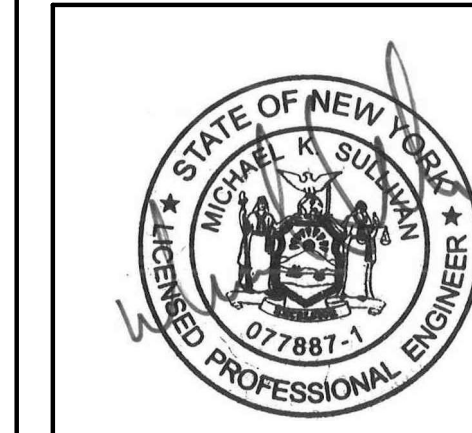

THESE DOCUMENTS AND ALL THE IDEAS, ARRANGEMENTS, DESIGNS AND PLANS INDICATED THEREON OR REPRESENTED THEREBY ARE OWNED BY AND REMAIN THE PROPERTY OF M.E. ENGINEERING AND NO PART THEREOF SHALL BE UTILIZED BY ANY PERSON, FIRM OR CORPORATION FOR ANY PURPOSE WHATSOEVER EXCEPT WITH THE SPECIFIC WRITTEN PERMISSION  
2021 © M.E. ENGINEERING, P.C.

REVISIONS				
No.	Date	By	Description	
1	09/27/22	ME	ADDENDUM #1	


**DRAWING TITLE**  
**BASEMENT PIPING PLAN**

**DRAWING NO.**  
**M200**  
Drawn By: Author  
Checked By: Checker  
Project Mgr: BAB  
Project No: 213212

**ISSUE DATE**  
**09/02/2022**  
Project Status

**DRAWING NOTES**

1. DISCONNECT PIPING AT POINT SHOWN BACK TO MAIN AS REQUIRED TO CONNECT TO COIL IN NEW WORK AIR HANDLING UNITS. PROVIDE ALL NEW VALVING PER PIPING DETAIL.
2. CONNECT CONDENSATE PIPING FROM UNIT AND ROUTE TO EXISTING FLOOR DRAIN. MODIFY FLOOR DRAIN AS REQUIRED FOR UNIT INSTALLATION.
3. IF ALTERNATE 2 IS TAKEN, DISCONNECT AND RELOCATE EXISTING 4" CWS/R AND 3"DWS PIPES IN AREA SHOWN AND REMOVE INSULATION. RISE PIPES AS HIGH AS POSSIBLE AND REINSTALL AND REINSULATE AS REQUIRED.
4. DISCONNECT AND REMOVE EXISTING ABANDONED 2" VACUUM LINE AS REQUIRED FOR UNIT INSTALLATION. CAP BOTH ENDS.

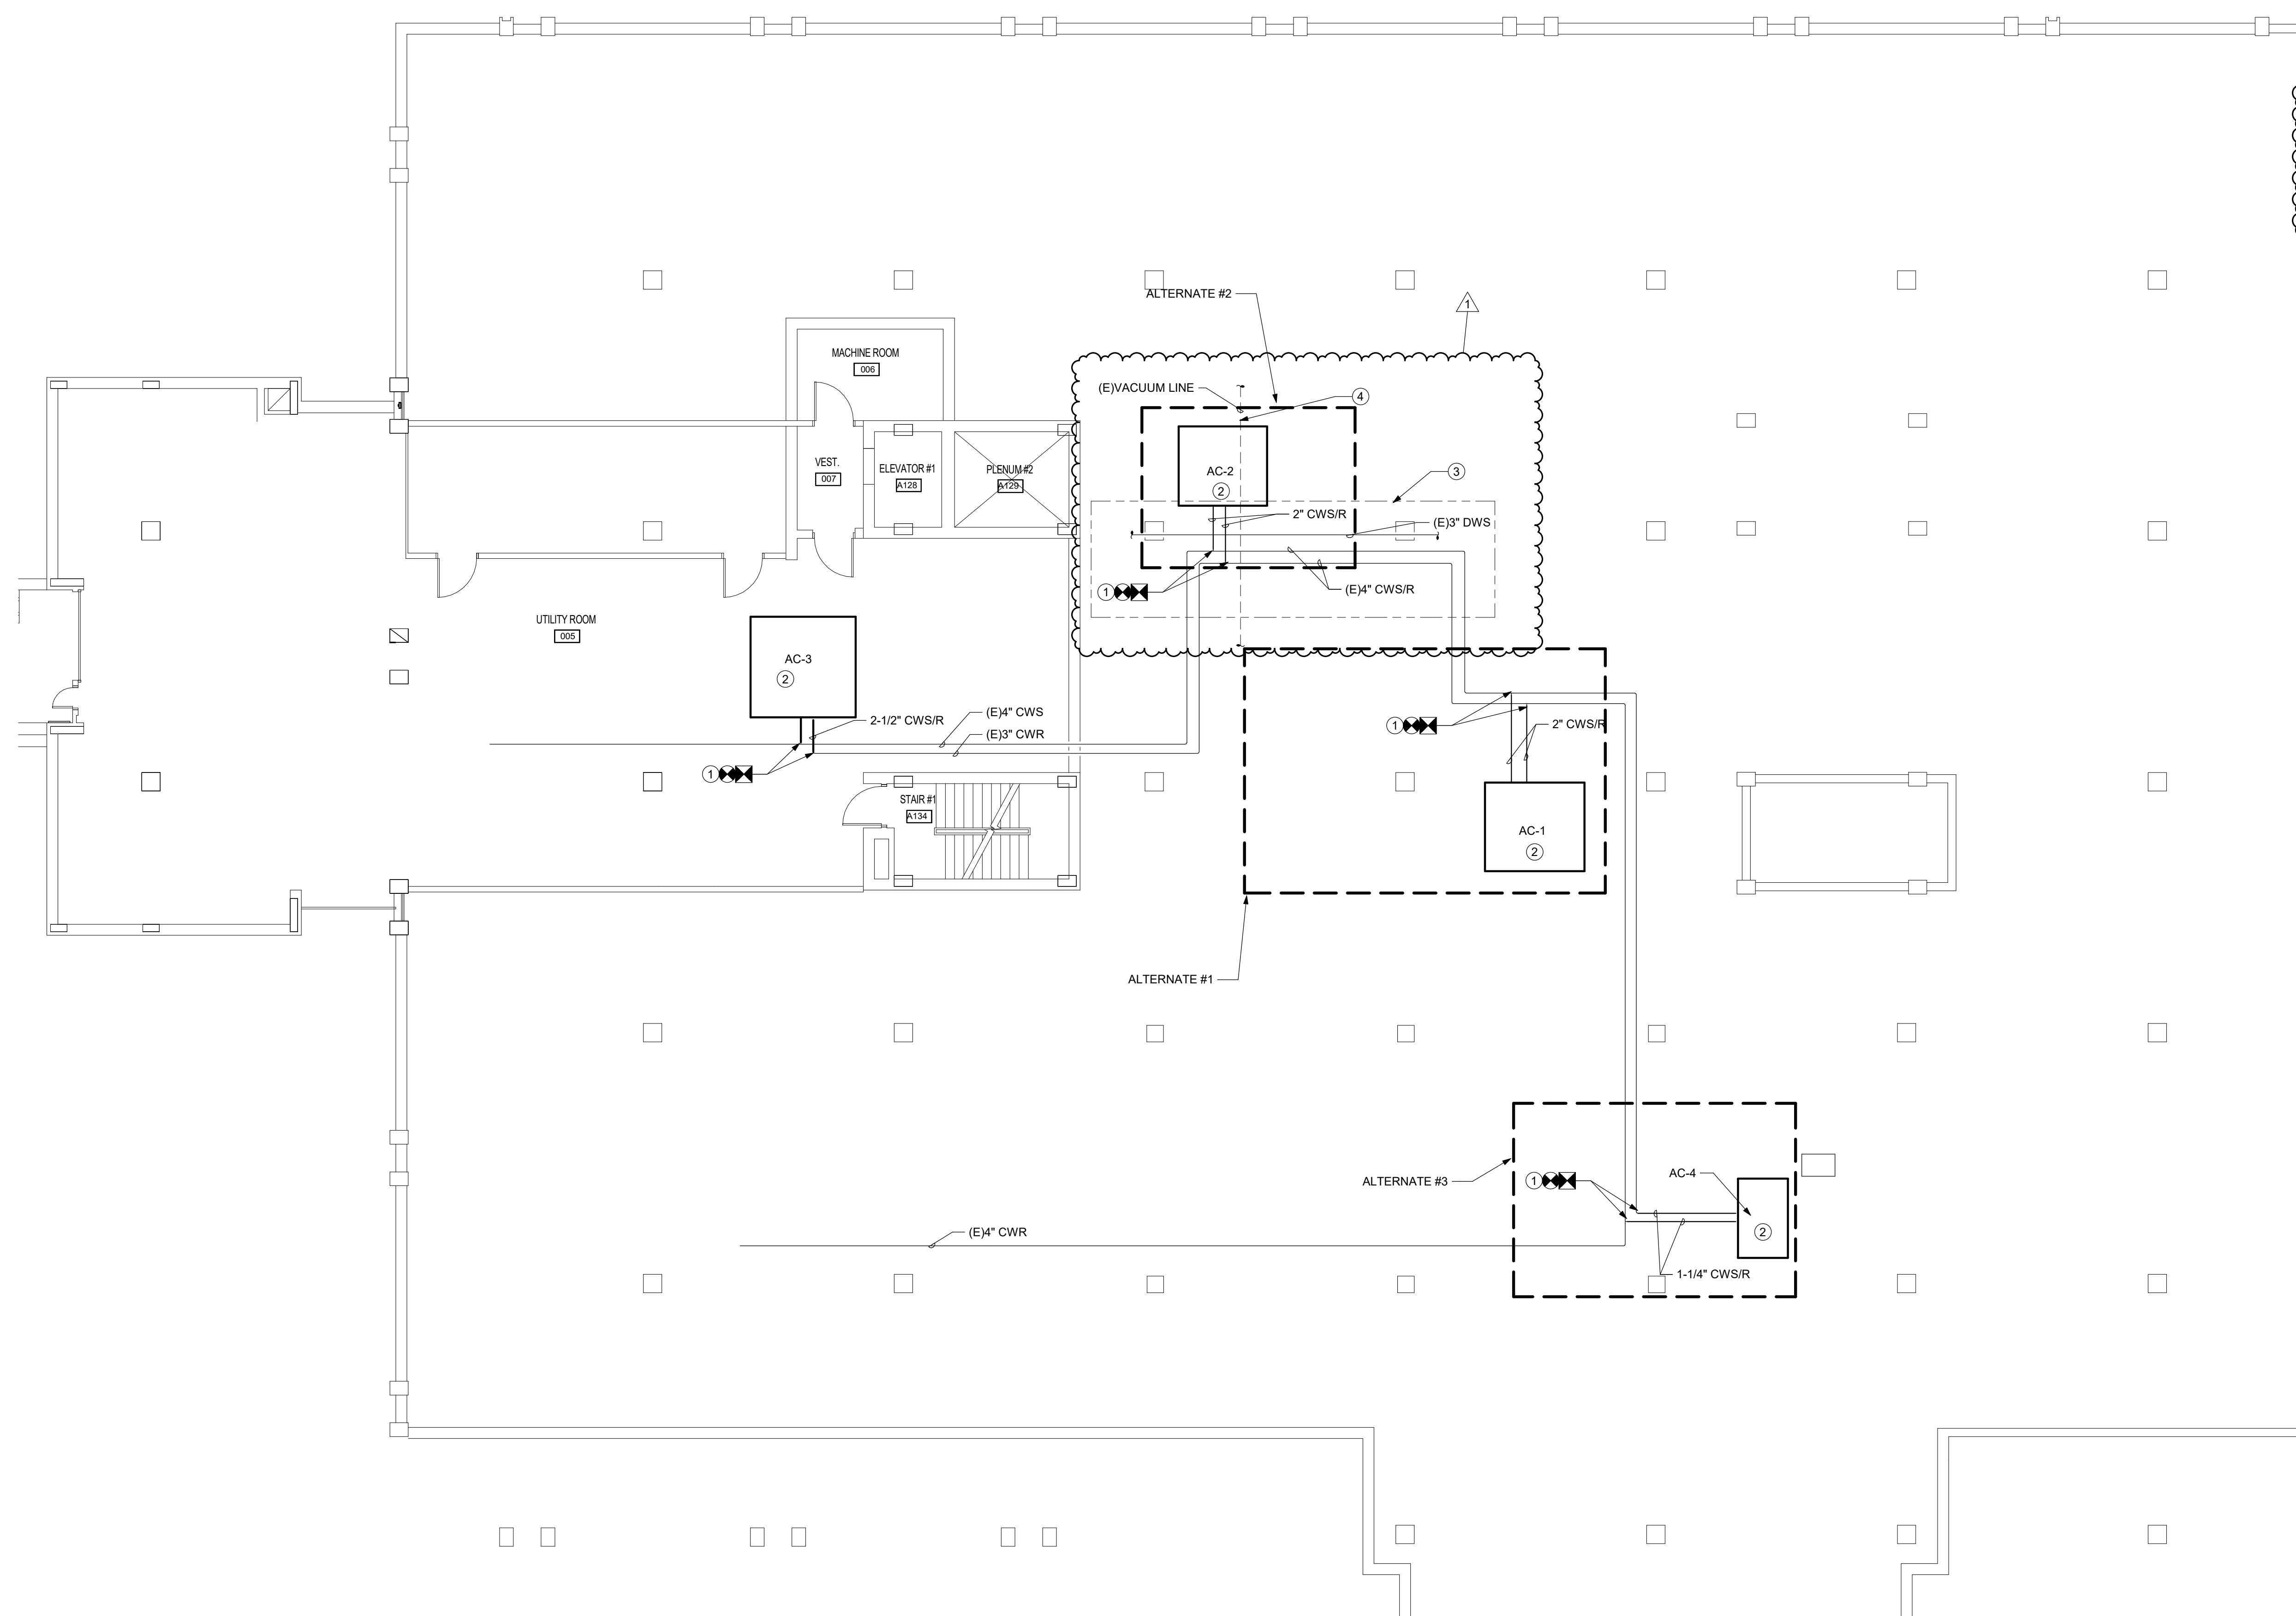

**1** Basement Piping Plan  
1/8" = 1'-0"

